


PROVIDE SPARE WIRES FROM EACH DEVICE TO INTERLOCK PANEL OR DESTINATION

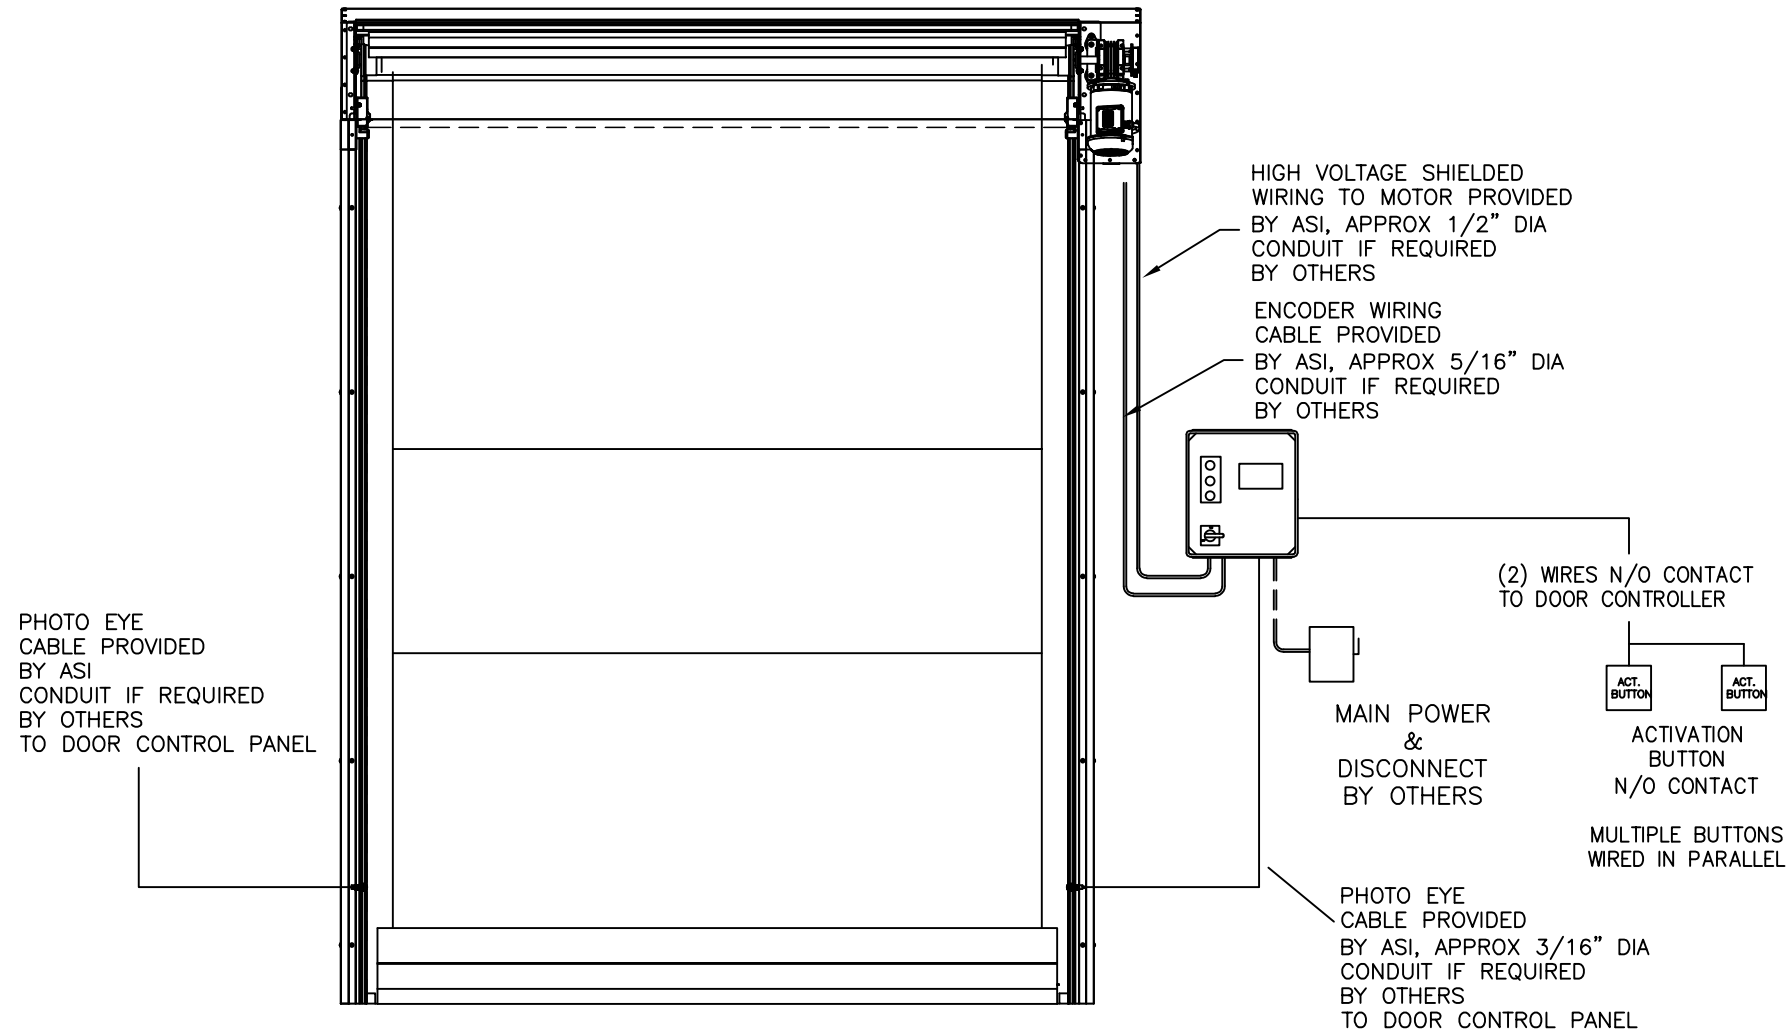

RIGHT HAND ASSEMBLY SHOWN

LEFT HAND ASEMBLY OPPOSITE

SPECIAL NOTES

- \* ALL NECESSARY WIRING TO BE SUPPLIED BY OTHERS
- \* CONTROL WIRING TO BE LOW VOLTAGE, 18AWG
- \* PROVIDE SPARE WIRES FROM EACH DEVICE



5848 North 95th Court  
Milwaukee, WI 53225  
1-800-558-7068  
www.asidoors.com

APPROVALS

FABRICATION CAN PROCEED ACCORDING TO THE SPECIFICATION SHOWN EXCEPT AS NOTED.

BY \_\_\_\_\_ DATE \_\_\_\_\_

ASI JOB NUMBER:  
CUSTOMER ORDER NUMBER:  
SOLD TO:  
SHIP TO:

QUANTITY OF DOORS:  
QUANTITY OF PRINTS:  
DOOR ASSEMBLY NO:  
ELECTRICAL DRAWING NO: -

TITLE  
215 FABRIC ROLL-UP  
ELECTRICAL RISER

DRAWN BY	DATE	SHEET	DRAWING NO.	REV.
DEN	12-7-12	1 OF 1	215-R1	